



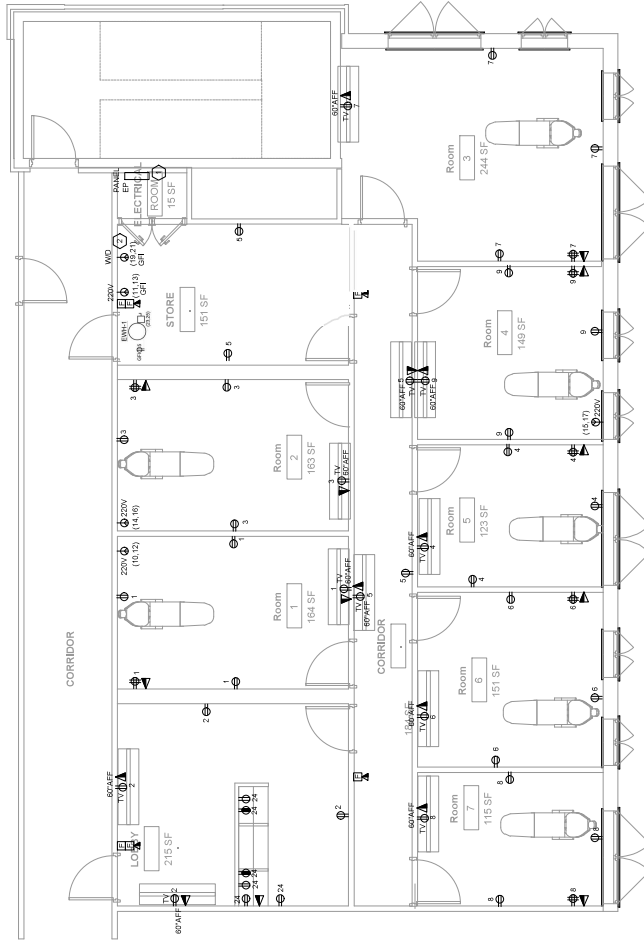

1 ELECTRICAL PLAN

Scale: 1/4"=1'-0"

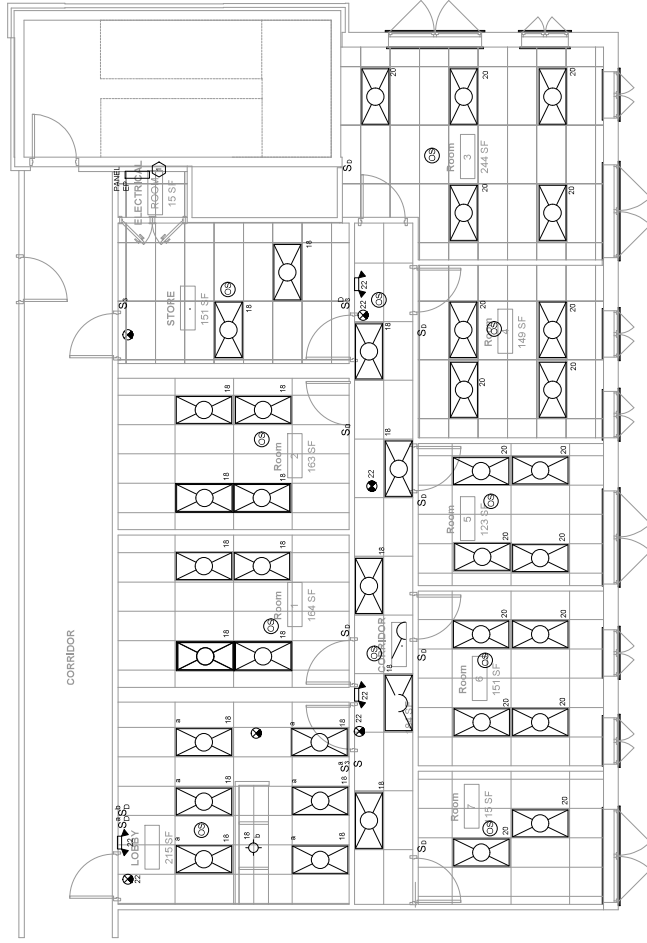

2 LIGHTING PLAN

Scale: 1/4"=1'-0"

NOTES:

1. REFER TO DWG. E01 FOR SYMBOL LIST, NOTES AND INFORMATION PANEL.
2. REFER TO DWG. E02 FOR ONE LINE DIAGRAMS AND PANEL SCHEDULES.
3. CONTRACTOR SHALL COORDINATE ALL LIGHTING FIXTURES AND DEVICES WITH ARCHITECT/OWNER.
4. COORDINATE ALL FINAL DEVICE AND PANEL LOCATIONS IN FIELD AND WITH ARCHITECT/INTERIOR DESIGNER.
5. ALL DEVICES SHALL BE CONNECTED TO PANELBOARD.
6. ALL FIRE ALARM DEVICES SHALL BE CONNECTED TO RELOCATED FIRE ALARM CONTROL PANEL, AND MATCH BUILDING STANDARDS.
7. ALL OCCUPANCY SENSORS SHALL HAVE MANUAL OVERRIDE.

KEYED NOTES

1. PANELBOARD E.P.
2. VENTLESS DRYER.


LIGHT FIXTURE SCHEDULE		
SYMBOL	MANUFACTURER & MODEL #	DESCRIPTION
	METALUX 2x4 LED PANEL - 2400PF640C	2x4 OR 2x2 A REQUIRED - LED PANEL, 4000K-120V
	HARLOW FACETED CRYSTAL CHANDELIER-SKU HARLOWC36000400	COORDINATE SELECTION WITH OWNER
	LUTRONA LIGHTING-DIMMER	30 WAX BATTERY BACKUP

LIGHTING FIXTURE SCHEDULE NOTES:

1. OR APPROVED EQUALS BY OWNER.

COPYRIGHT

THIS DRAWING IS THE PROPERTY OF TEJJY INC. REPRODUCTION OR USE IN WHOLE OR IN PART WITHOUT PERMISSION IS STRICTLY PROHIBITED.

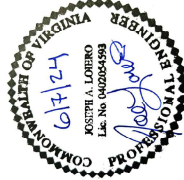

Project Name

4565 Daisy Reid Ave,
Woodbridge, VA

REV.	DATE	DESCRIPTION

PM :

Author :

Checker :

Scale : As indicated

SHEET TITLE

ELECTRICAL AND
LIGHTING PLANS

SHEET NO.

E101



1801 Research BLVD STE 110,
Rockville, MD 20850
call: 202-465-4830
email: info@tejjy.com